

ECN NO	DESCRIPTION	Drawn

E.CPK Measure point Y1-Y4.

D.CONDUCTIVE RESISTANCE: 0.4<10FT 2 ohm (MAX)
 10FT<15FT 3 ohm (MAX)
 15FT<30FT 4 ohm (MAX)
 30FT<100FT 6 ohm (MAX)

C.INSULATION RESISTANCE: 20M ohm (MIN)
 B.HI-POT: 300V DC/sec

A.OPEN/SHORT/INTERMITTENCE: 100%

ELECTRONIC TEST:

10.NOT RECOMMENDED USING ANY CABLE EXTENSIONS. VIDEO MAY APPEAR DIM OR NOT AT ALL.

9.LABEL: YEAR MONTH LABEL

8.THUMBSCREW NUT:#4-40UNC SHELL NICKEL PLATED

7. LABEL:BLACK BOX"DDC"LABEL

6. LABEL:BLACK BOX P/N LABEL

5. MOLDING PVC COLOR: BEIGE

4. THUMBSCREW: #4-40UNC COLOR:BEIGE

SHELL NICKEL PLATED

3. CONNECTOR:HDD15P FEMALE INSULATOR BLUE

SHELL NICKEL PLATED

2. CONNECTOR:HDD15P MALE EMPTY 9 INSULATOR BLUE

746-5500 E223178 AWM STYLE 20276 80°C 30V VW-1

MARKING: BLACK BOX CORPORATION GUARANTEED FOR LIFE (724)

1. CABLE:UL20276 1354(S)30AWG3C+30AWG3C+30AWG*8C+AEB(AL) 85%

MATERIALS LIST:

ELECTRONIC TEST:
 A. OPEN/SHORT/INTERMITTENCE: 100%.
 B. HI-POT: 300V AC/sec,300V DC/sec
 C. INSULATION RESISTANCE: 20M OHM (MIN)
 D. CONDUCTIVE RESISTANCE: 2 OHM (MAX)

Tolerance:
 X. ±
 .XX ±
 .XXX ±
 Angle:
 X. ±
 X. ±
 X. ±





BLACK BOX

Approved by:
 Checked by:
 BBOX P/N:
 Description:
 Drawn by:
 Date:
 Scale:
 Unit: inch

EVN21VGA
 VGA Splitter Cable

11.08.03
 DWG. NO:
 SHEET: 1 OF 4
 REV: 01

P2	P1	P3
1 RED COAX	1 RED GND	1 RED COAX
2 GREEN COAX	2 GREEN GND	2 GREEN COAX
3 BLUE COAX	3 BLUE GND	3 BLUE COAX
4 BLACK	4 BLACK	4 BLACK
5 BROWN	5 BROWN	5 BROWN
6 RED	6 RED	6 RED
7 YELLOW	7 YELLOW	7 YELLOW
8 GRAY	8 GRAY	8 GRAY
9 WHITE	9 WHITE	9 WHITE
10 SHELL	10 SHELL	10 SHELL
11 DRAIN WIRE	11 DRAIN WIRE	11 DRAIN WIRE
12 SHELL	12 SHELL	12 SHELL
13 DRAIN WIRE	13 DRAIN WIRE	13 DRAIN WIRE
14 SHELL	14 SHELL	14 SHELL
15 DRAIN WIRE	15 DRAIN WIRE	15 DRAIN WIRE

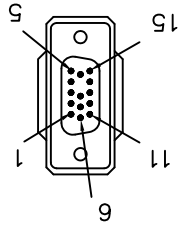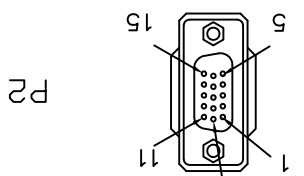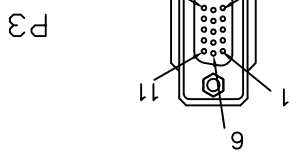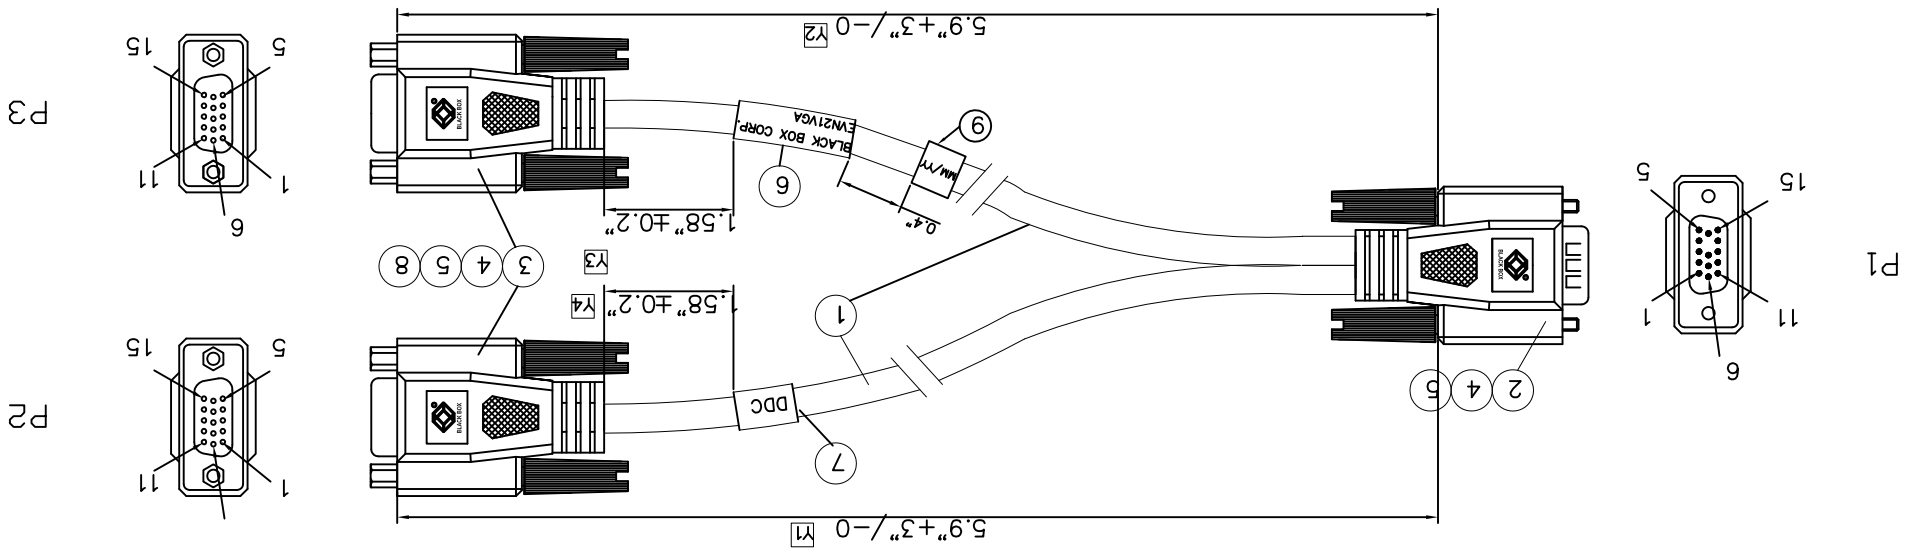

X-ON Electronics

Largest Supplier of Electrical and Electronic Components

Click to view similar products for [black box manufacturer](#):

Other Similar products are found below :

[MED100A](#) [BC00231](#) [IC820A](#) [EVNSL81-0020](#) [LGH008A](#) [LBH100AE-H-PS](#) [FT3401](#) [FMTP5ES-10PAK](#) [LBS005A](#) [EL06MS-04](#) [FA440-R2](#)
[EL04MS-04](#) [FMT1081](#)