


ALL MATERIAL ARE ROHS AND CALIFORNIA PROP.65 COMPLIANT

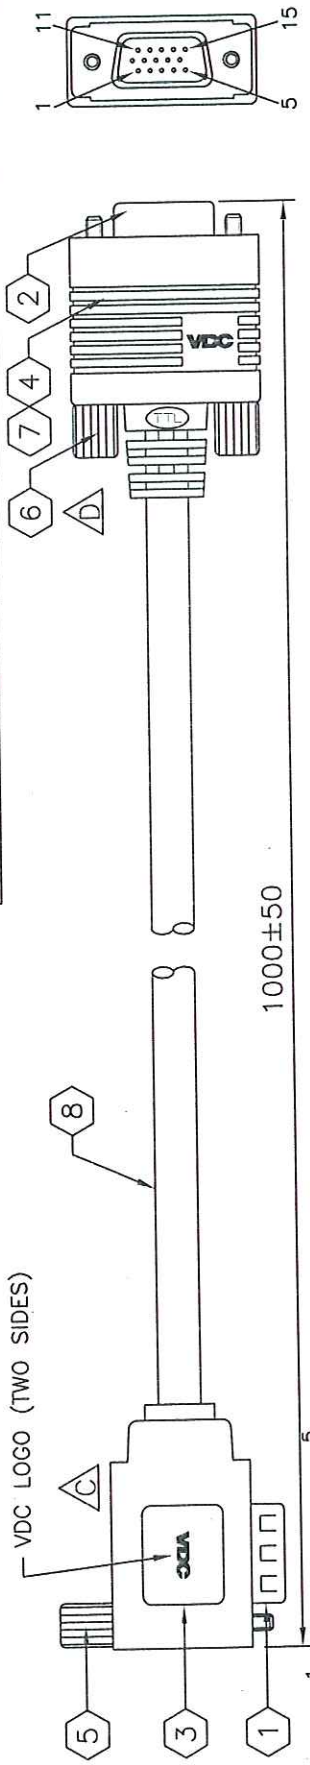

CUSTOMER'S APPROVAL: \_\_\_\_\_  
 FIRST ARTICLE SAMPLE REQUIRED:  YES,  NO.

DATE: \_\_\_\_\_  
 NO. \_\_\_\_\_



HD15 (90°) MALE	HD15 FEMALE
1	Red Video
2	Green Video
3	Blue Video
4	Ground
5	Red Ground
6	Green Ground
7	Blue Ground
8	+5 VDC
9	
10	
11	
12	DDC Serial Data Line
13	Horizontal Sync (or Composite Sync)
14	Vertical Sync
15	DDC Data Clock Line
SHELL	DRAIN+BRAID
	SHELL

WIRE MARKING:  
 VDC LONDON WWW.VDCTRADING.COM  
 E193793 9J AWM 2919 80°C 30V VW-1

ITEM	DESCRIPTION	QTY.	UNIT
1	HD15 MALE CONNECTOR	1	PCS.
2	HD15 FEMALE CONNECTOR	1	PCS.
3	PANTONE BLUE 072U MOLDED PVC HOOD W/VDC LOGO (90°)	1	PCS.
4	PANTONE BLUE 072U MOLDED PVC HOOD W/VDC LOGO	1	PCS.
5	PANTONE BLUE 072U #4/40 THUMBSCREW	1	PCS.
6	BLUE #4/40 THUMBSCREW	2	PCS.
7	PAT. NO.:US 6,287,148 B1 RF-BLOK™ SHIELDING METAL CAN	1	PCS.
8	UL2919 (28AWG COAX+AL-FOIL+65%BRAID+INNER JACKET)x3C SEE DWG. +(28AWG WIRE)x8C+AL-FOIL+DRAIN+BRAID OVERALL;	SEE	DWG.
	PANTONE BLUE 072U PVC JACKET		

UNIT: mm

REV.	DESCRIPTION	DATE	REVISED BY
A	REVISE PINOUT	JUN.06.07	STANLEY
B	CHANGE WIRE SPEC.	JUN.07.07	STANLEY
C	REMOVE ONE SCREW	JUL.30.07	STANLEY
D	CHANGE ITEM#6 FROM HEXNUT TO THUMBSCREW	OCT.08.08	STANLEY

Customer's P/N:	104-300301	Revision:	D
RFQ number:	96060105	Drawing#:	96060105
Drawn by:	STANLEY	Scale:	None
Checked by:		Date:	06/01/2007
SALES: JOAN		Copyright 06-2007	
TOTAL TECHNOLOGIES, LTD.		Studebaker, Irvine, CA 92618	
1-800-669-4885			

All information herein is proprietary and the exclusive property of Total Technologies, Ltd. Recipient agrees: 1) Not to disclose any of such information to others 2) Not to reproduce in whole or in part 3) To use such information only as directed by Total Technologies, Ltd. 4) Upon request, to return all copies of this document to Total Technologies, Ltd. Specifications are subject to change without prior notice.

## **X-ON Electronics**

Largest Supplier of Electrical and Electronic Components

*Click to view similar products for [vdc manufacturer](#):*

Other Similar products are found below :

[104911003](#) [104911913](#) [101-003-202](#) [101-066-001](#) [111-548-052](#) [111-544-052](#) [401-026-001](#) [104-084-100](#) [110-102-000](#) [104238206](#) [110-065-000](#) [104911005](#) [104911912](#) [104400401](#) [104910003](#) [110-064-000](#) [110180929](#) [104-082-070](#) [104600030](#) [110-824-050](#) [104-080-035](#)  
[104911101](#) [110028919](#)