


ALL MATERIAL ARE RoHS AND CALIFORNIA PROP.65 COMPLIANT



CUSTOMER'S APPROVAL: _____ DATE: _____
 FIRST ARTICLE SAMPLE REQUIRED: YES, NO.

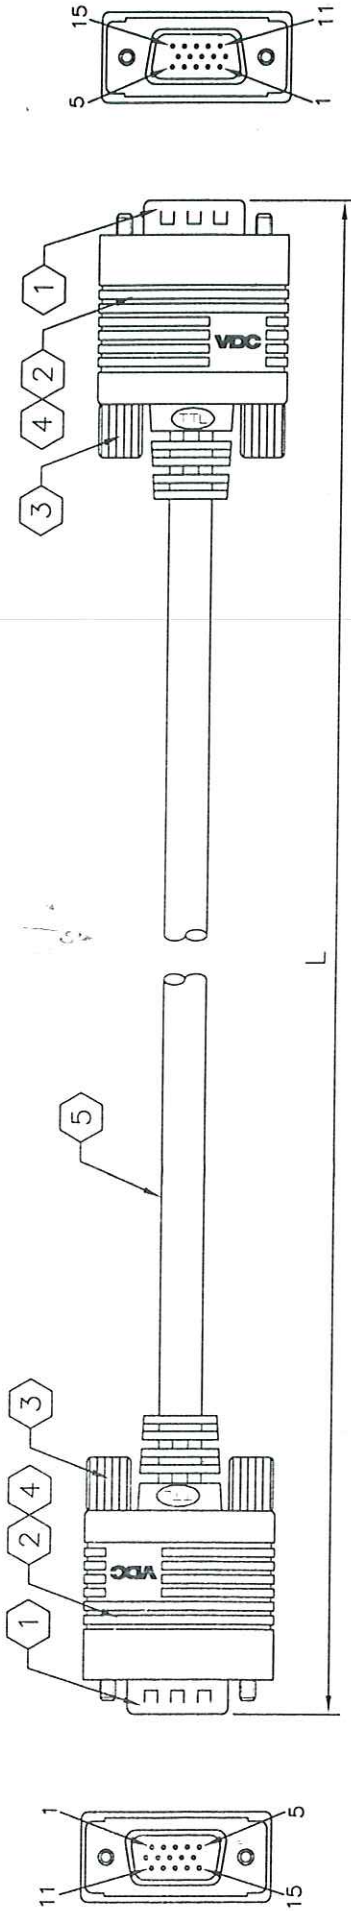

PINOUT CONFIGURATION

HD15 MALE	HD15 MALE
1	Red Video
2	Green Video
3	Blue Video
4	Ground
5	Red Ground
6	Green Ground
7	Blue Ground
8	+5 VDC
9	
10	
11	
12	DDC Serial Data Line
13	Horizontal Sync (or Composite Sync)
14	Vertical Sync
15	DDC Data Clock Line
SHELL	DRAIN+BRAID
	SHELL

P/N	L±(mm)
104233005	500±50
104234202	2000±50
104236203	3000±100
104238206	6000±200
104240210	10000±250
104241215	15000±250
104242220	20000±250
104244230	30000±250
104246250	50000±250

WIRE MARKING:
 VDC LONDON WWW.VDCTRADING.COM
 E193793 RJ AWM 2919 80°C 30V VW-1

UNIT: mm

ITEM	DESCRIPTION	QTY.	UNIT
1	HD15 MALE CONNECTOR	2	PCS.
2	PANTONE BLUE 072U MOLDED PVC HOOD W/VDC LOGO	2	PCS.
3	PANTONE BLUE 072U #4/40 THUMBSCREW	4	PCS.
4	PAT. NO.:US 6,287,148 B1 RF-BLOK™ SHIELDING METAL CAN	2	PCS.
5	UL2919 (28AWG COAX+AL-FOIL+65%BRAID+INNER JACKET)x30 DWG. + (28AWG WIRE)x8C+AL-FOIL+DRAIN+BRAID OVERALL;	SEE DWG.	
	PANTONE BLUE 072U PVC JACKET		

REV.	DESCRIPTION	DATE	REVISED BY	Customer's P/N:	Revision:
A	REVERSE PINOUT	JUN.06.07	STANLEY	SEE TABLE	B
B	CHANGE WIRE SPEC.	JUN.07.07	STANLEY		
				RFQ number:	96060102
				Drawn by:	STANLEY
				Checked by:	None
				Date:	06/01/2007
				SALES:	JOAN

Copyright 06-2007
TOTAL TECHNOLOGIES, LTD.
 9 Studebaker, Irvine, CA 92618
 1-800-869-4885

All information herein is proprietary and the exclusive property of Total Technologies, Ltd. Recipient agrees: 1) Not to disclose any of such information to others 2) Not to reproduce in whole or in part 3) To use such information only as directed by Total Technologies, Ltd. 4) Upon request, to return all copies of this document to Total Technologies, Ltd. Specifications are subject to change without prior notice.

X-ON Electronics

Largest Supplier of Electrical and Electronic Components

Click to view similar products for [vdc manufacturer](#):

Other Similar products are found below :

[104911003](#) [104911913](#) [101-003-202](#) [101-066-001](#) [111-548-052](#) [111-544-052](#) [401-026-001](#) [104-084-100](#) [110-102-000](#) [104238206](#) [110-065-000](#) [104911005](#) [104911912](#) [104400401](#) [104910003](#) [110-064-000](#) [110180929](#) [104-082-070](#) [104600030](#) [110-824-050](#) [104-080-035](#)
[104911101](#) [110028919](#)