


ALL MATERIAL ARE RoHS AND CALIFORNIA PROP.65 COMPLIANT

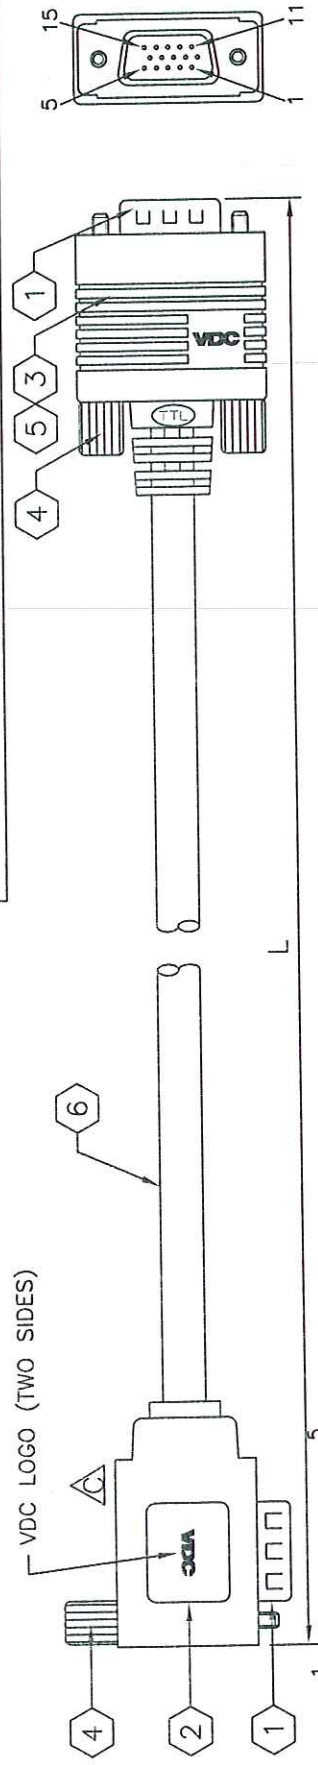

CUSTOMER'S APPROVAL: _____ DATE: _____
 FIRST ARTICLE SAMPLE REQUIRED: YES, NO.



HD15 (90°C) MALE	HD15 MALE
1	Red Video
2	Green Video
3	Blue Video
4	Ground
5	Red Ground
6	Green Ground
7	Blue Ground
8	+5 VDC
9	
10	
11	
12	DDC Serial Data Line
13	Horizontal Sync (or Composite Sync)
14	Vertical Sync
15	DDC Data Clock Line
SHELL	DRAIN+BRAID

WIRE MARKING:
 VDC LONDON WWW.VDCTRADING.COM
 E193793 RU AWM 2919 80°C 30V VW-1

P/N	L±(mm)
104400401	1000±50
104400403	3000±100
104400405	5000±150

ITEM	DESCRIPTION	QTY.	UNIT
1	HD15 MALE CONNECTOR	2	PCS.
2	PANTONE BLUE 072U MOLDED PVC HOOD W/VDC LOGO (90°)	1	PCS.
3	PANTONE BLUE 072U MOLDED PVC HOOD W/VDC LOGO	1	PCS.
4	PANTONE BLUE 072U #4/40 THUMBSCREW	3	PCS.
5	PAT. NO.:US 6,287,148 B1 RF-BLOK™ SHIELDING METAL CAN	1	PCS.
6	UL2919 (28AWG COAX+AL-FOIL+65%BRAID+INNER JACKET)x3C + (28AWG WIRE)x8C+AL-FOIL+DRAIN+BRAID OVERALL;	SEE DWG.	DWG.
	PANTONE BLUE 072U PVC JACKET		

REV.	DESCRIPTION	DATE	REVISED BY
A	REVISE PINOUT	JUN.06.07	STANLEY
B	CHANGE WIRE SPEC.	JUN.07.07	STANLEY
C	REMOVE ONE SCREW	JUL.30.07	STANLEY
D	ADD LENGTH 5M	SEP.15.08	STANLEY

REVISED DETAILS	Customer's P/N:	Revision:	SALES:
SEE TABLE	D	D	JOAN
RFQ number:	96060104	Drawing#:	
Drawn by:	STANLEY	Scale:	None
Checked by:		Date:	06/01/2007
Copyright 06-2007		TOTAL TECHNOLOGIES, LTD.	
		9 Studebaker, Irvine, CA 92618	
		1-800-669-4885	

All information herein is proprietary and the exclusive property of Total Technologies, Ltd. Recipient agrees: 1) Not to disclose any of such information to others 2) Not to reproduce in whole or in part 3) To use such information only as directed by Total Technologies, Ltd. 4) Upon request, to return all copies of this document to Total Technologies, Ltd. Specifications are subject to change without prior notice.

X-ON Electronics

Largest Supplier of Electrical and Electronic Components

Click to view similar products for [vdc manufacturer](#):

Other Similar products are found below :

[104911003](#) [104911913](#) [101-003-202](#) [101-066-001](#) [111-548-052](#) [111-544-052](#) [401-026-001](#) [104-084-100](#) [110-102-000](#) [104238206](#) [110-065-000](#) [104911005](#) [104911912](#) [104400401](#) [104910003](#) [110-064-000](#) [110180929](#) [104-082-070](#) [104600030](#) [110-824-050](#) [104-080-035](#)
[104911101](#) [110028919](#)