


**NOTES:**


1. FINISHED CABLE ASSEMBLY TO BE COILED
2. OVERMOLD BOOT MATERIAL: PVC, BLACK
3. ELECTRICAL TEST: 100% CONTINUITY

ASS'Y P/N	NO. OF POS.	"X" DIM.
CA62802S07990	2	6 FT 7 IN. ± 2 IN. [2M]
CA62803S07990	3	
CA62804S07990	4	
CA62805S07990	5	
CA62806S07990	6	
CA62807S07990	7	
CA62808S07990	8	
CA6280XSXXX90		


— CABLE LENGTH IN "INCHES"  
— NO OF POSITIONS

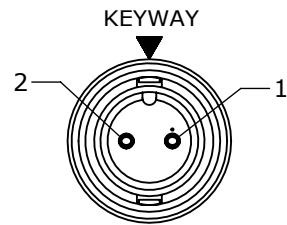


**FACE VIEW**  
P/N: CA62802SXXX90

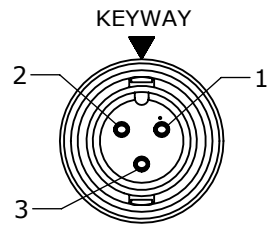


**FACE VIEW**  
P/N: CA62803SXXX90

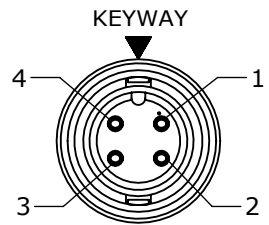


**FACE VIEW**  
P/N: CA62804SXXX90

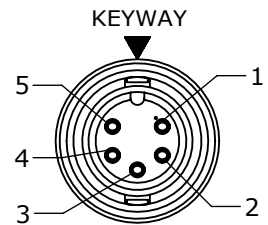


**FACE VIEW**  
P/N: CA62805SXXX90

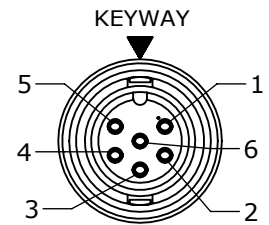


**FACE VIEW**  
P/N: CA62806SXXX90

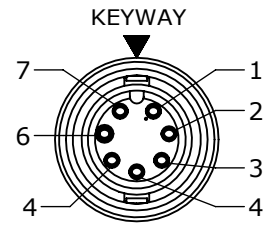


**FACE VIEW**  
P/N: CA62807SXXX90

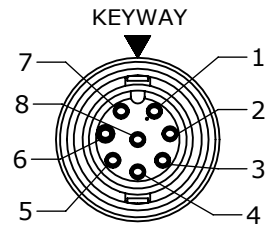

**FACE VIEW**  
CA62808SXXX90

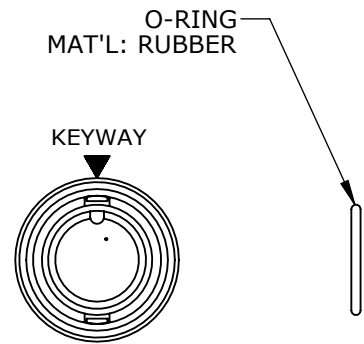

**END "A" FACE VIEW**

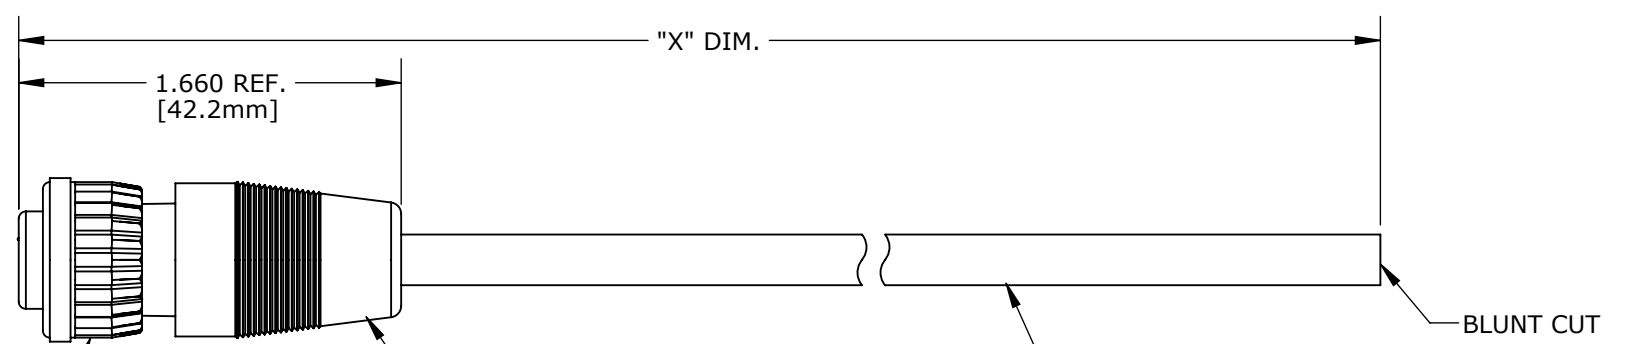

ASSY P/N	CABLE	COLOR CODE END "A"							
CA62802SXXX90	2/20 AWG O.D. 0.215 REF	COLOR CODE							
		POS. 1	POS. 2						
CA62803SXXX90	3/20 AWG O.D. 0.220 REF	WIRE COLOR CODE							
		POS. 1	POS. 2	POS. 3					
		BLK	WHT	GRN					
CA62804SXXX90	4/20 AWG O.D. 0.235 REF	WIRE COLOR CODE							
		POS. 1	POS. 2	POS. 3	POS. 4				
		BLK	WHT	GRN	RED				
		WIRE COLOR CODE							
CA62805SXXX90	5/20 AWG O.D. 0.255 REF	POS. 1	POS. 2	POS. 3	POS. 4	POS. 5			
		BLK	WHT	GRN	RED	BLU			
		WIRE COLOR CODE							
		POS. 1	POS. 2	POS. 3	POS. 4	POS. 5	POS. 6		
		BLK	WHT	GRN	RED	BLU	VIO		
CA62807SXXX90	8/20 AWG O.D. 0.300 REF	WIRE COLOR CODE							
		POS. 1	POS. 2	POS. 3	POS. 4	POS. 5	POS. 6	POS. 7	
		BLK	WHT	GRN	RED	BLU	VIO	GRY	
		WIRE COLOR CODE							
		POS. 1	POS. 2	POS. 3	POS. 4	POS. 5	POS. 6	POS. 7	POS. 8
		BLK	WHT	GRN	RED	BLU	VIO	GRY	BRN
		WIRE COLOR CODE							
CA62808SXXX90	8/20 AWG O.D. 0.300 REF	POS. 1	POS. 2	POS. 3	POS. 4	POS. 5	POS. 6	POS. 7	POS. 8
		BLK	WHT	GRN	RED	BLU	VIO	GRY	BRN

DIMENSIONS IN BRACKET [ ] ARE METRIC.

**RoHS COMPLIANT**

**CUSTOMER APPROVAL**

THIS DOCUMENT CONTAINS CONFIDENTIAL INFORMATION PROPRIETARY TO CONXALL CORPORATION. ANY REPRODUCTION, DISCLOSURE, OR USE OF THIS DOCUMENT /INFORMATION IS EXPRESSLY PROHIBITED UNLESS AUTHORIZED IN WRITING BY CONXALL CORPORATION.

APPROVED BY: \_\_\_\_\_

DATE: \_\_\_\_\_

A	AN	06-07-16	DRAWING CREATED PER DOR 16-7414JP
REV.	INIT.	DATE	DESCRIPTION
	AN	05-25-16	ORIG. DRAWN BY: AN DATE: 05-25-16
ALL INFORMATION ILLUSTRATED IS THE PROPERTY OF CONXALL CORPORATION. UNAUTHORIZED DUPLICATION OR DISTRIBUTION OF THIS DOCUMENT IS PROHIBITED.			<p>601 E. WILDWOOD VILLA PARK, IL 60181</p>
ALL UNITS ARE IN FEET, INCHES, FRACTION OF INCHES AND DECIMALS.			
APPROVED BY:		TITLE: CABLE ASSEMBLY (2-8) #20 SOCKET CONTACTS MINI-CON-X	
SCALE: NTS	SIZE: B	SHEET: 1 OF 1	CUSTOMER: STANDARD PRODUCT
FILE: CA6280XSXXX90	DIRECTORY: SLW	PART NUMBER: CA6280XSXXX90	REV: A

CUSTOMER PRINT

PART NUMBER: CA6280XSXXX90

## X-ON Electronics

Largest Supplier of Electrical and Electronic Components

*Click to view similar products for [Specialised Cables category](#):*

*Click to view products by [Switchcraft manufacturer](#):*

Other Similar products are found below :

[603PT6](#) [603SS6L](#) [604PT6](#) [604SS6](#) [706000D02F200](#) [910640](#) [1200740077](#) [1200740114](#) [AC172](#) [ACL-SSI-4](#) [R88ACAKA0015SRE](#)  
[R88ACAWL005SDE](#) [R88ACRGD0R3C](#) [1300150047](#) [1300660036](#) [1302262116](#) [1300150149](#) [1300220020](#) [1300220104](#) [1300220119](#)  
[1301240492](#) [1301810221](#) [1365323-1](#) [1613055](#) [176P12](#) [1971465-2](#) [20240400003](#) [20240400013](#) [2085828-1](#) [20886510030](#) [2-22733-8](#) [22733-](#)  
[8](#) [CB-5PSBC-RS](#) [CB-704EC-RS](#) [CB-BATACC-RS](#) [CB-JST3PSW-RS](#) [CB-M12COM-R10](#) [25AC84](#) [25AK84X](#) [25AU25](#) [25FN82](#) [3011-03](#)  
[AC118](#) [ACL-HHS-1M\(CAT5E\)](#) [SSL009PC2DC012N](#) [FC2A-KC6C](#) [2085828-2](#) [20886510150](#) [CCS-FCB-5](#) [CCSFCBF2](#)